

SHOWER MIXER SET
SN 1202

FLOOR DRAIN
SN 1408

RAIN SHOWER
SN 1203

PAPER HOLDER
SN 1501

TRASH BIN
SN 1601

BRUSH HOLDER
SN 1602

FLUSH
SN 1403

WATER CLOSET
SN 1301

SPRAY BIDET
SN 1201

VANITY MIRROR
SN 1001

HOOK
SN 1502


HOOK
SN 1502

BASIN DRAIN
SN 1410

SIPHON
SN 1411

WASH BASIN
SN 1101

FAUCET MIXER SET
SN 1204

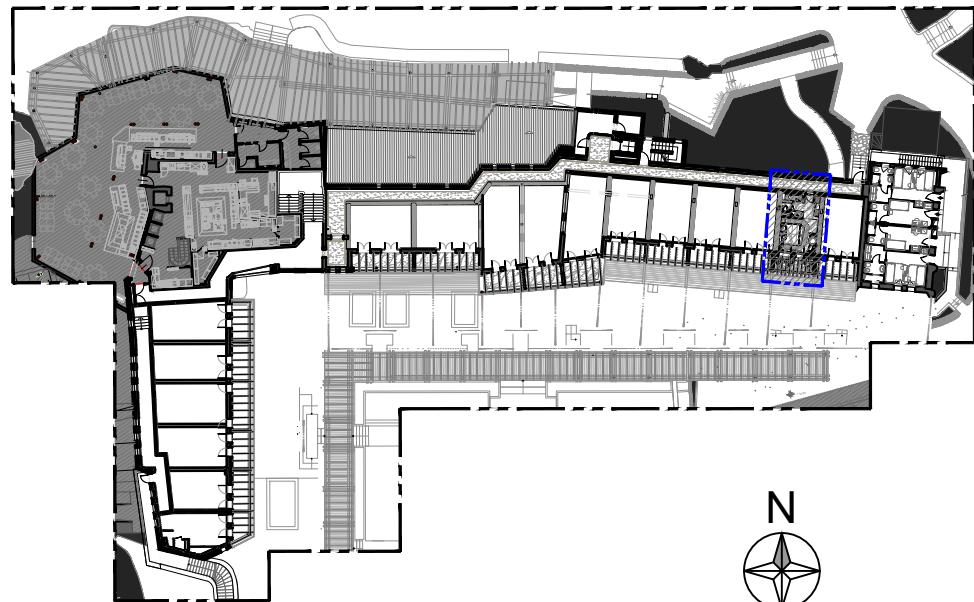


KEY PLAN
SCALE 1:750 (A1) / 1:1500 (A3)

GENERAL NOTES
DO NOT TAKE MEASUREMENT DIRECTLY ON THE DRAWING.
ANY DISCREPANCY BETWEEN THIS DRAWING AND OTHER INFORMATION MUST BE REPORTED TO POD ARCHITECTURE.
FOR UNDER CONSTRUCTION OR EXISTING BUILDING, CONTRACTOR IS REQUIRED TO VERIFY THE CORRESPONDENCE BETWEEN THE REAL DIMENSIONS POINTED ON SITE AND THOSE LISTED ON THE DRAWING.
IN CASE OF DISCREPANCY BETWEEN THIS DRAWING AND APPROVED DRAWINGS OF SUBCONTRACTOR, SUBCONTRACTOR'S DRAWINGS ARE PRIORITY.
CONFLICT ARISING OUT OF THE INFORMATION AS INDICATED ABOVE MUST BE REPORTED IMMEDIATELY TO POD ARCHITECTURE.
THIS DRAWING IS THE INTELLECTUAL PROPERTY OF POD ARCHITECTURE.
DIMENSIONS ARE IN MILLIMETERS UNLESS OTHERWISE STATED.

NOTE:
ALL GENERAL DIMENSIONS ARE INDICATIVE ONLY. PLEASE REFER TO EXISTING SITE TO CHECK IF GIVEN DIMENSIONS ARE APPLICABLE. ADJUST TO FIT WHEN NECESSARY.

Legend

Keyplan

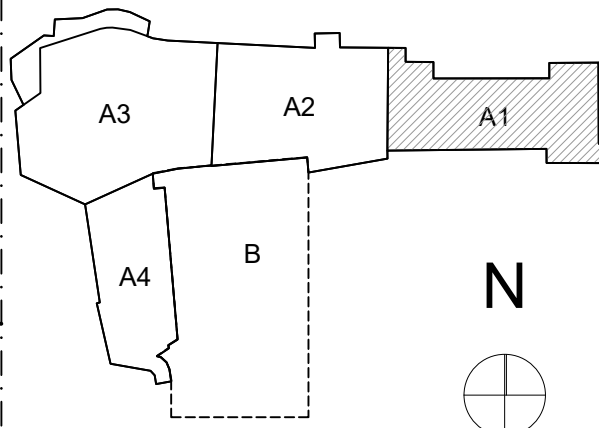

01

SANITARY PLAN

SCALE 1:25 (A1) / 1:50 (A3)

Proprietà
Smeralda Holding
Smeralda Holding Srl
Casa Il Ginepro 1/a,
07021, Porto Cervo (OT)

Project Management
CUSHMAN & WAKEFIELD
Cushman & Wakefield
Via Filippo Turati, 10/18, 20121, Milano
Arch. Benedetta Alghottini
Arch. Gianluca Di Cristofaro

Architect
LEV | Arch
Lev arch srl
Via Boccaccio 29 20123 Milano
Arch. Luca Colombo

Local Architect - Structural Engineer
Studio Ingegneria Cannas
Via Georgia - Geocity torre 3, 07026, Olbia (SS)
Ing. Danilo Cannas

Fire - Acoustic Consultant
Inalco s.r.l.
Corso Telesio, 107/a, 10149, Torino
Arch. Emanuela Pignatelli
Ordine Architetti di Torino n. TQ04836AD1207

System Engineer
BMC engineering s.r.l.
Via Benozzi, 6, 20122, Milano
Ing. Antonio Abramo Bazzoni Regazzini
Ordine Ingegneri di Milano n. 34543

Interior Designer
ATELIER POD
Atelier POD
301 JLT Dubai UAE, PO 337416, Tel 0442127701
Laurine Higeli
Javier Luc Delar

Le basi del disegno derivano dai seguenti documenti: *Tennis club drawings starting points* are Base grafica degli esterni: Rilievo del 2004; *Exterior drawings: 2004 Survey*;
Base grafica dell'edificio: Stato di Fatto Ing. Cannas del 17/07/2023; *Building drawings: 17/07/2023 As Built from Ing. Cannas*;
Base grafica di quote e info interne all'edificio: Sanatoria Ing. Cannas del 23/07/2022 e rilievo 09/2023
Interior and exterior levels: 23/07/2022 amnesty from Ing. Cannas + 09/2023 survey
NB. Le quote di livello del rilievo 2004 (xxx) differiscono dalle ultime del rilievo 2023 (xxx) di circa 1, 30mt
Levels from 2004 survey (xxx) and the last from 2023 survey (xxx) differs by 1, 30mt



MOCK-UP ROOM DETAIL DESIGN
First Floor Guestroom 103

Project
Cervo Tennis Club
Municipality
Arzachena

Sheet Title
**GUESTROOM MUR
SANITARY PLAN**
Scale
AS SHOWN
No. Drawing
CTC_MOC_ID_PJ_306_A1

digital file index
CTC_MOC_ID_PJ_300_A1 King Plans.dwg
Date
2024.02.20
Format
A1

Revision		DATE	REVISION	BY	CHKD	DATE
A	2024.02.20	04/04	DD P1 - FIRST ISSUE	LH	KM	-
B	2024.03.01	04/04	DD P1 - SECOND ISSUE	LH	KM	-
C	2024.03.22	04/04	DD P1 - THIRD ISSUE	LH	KM	-
D	2024.05.03	04/04	DD P1 - FOURTH ISSUE	LH	KM	-
E	2024.09.27	04/04	DD P1 - FIFTH ISSUE	LH	KM	-

**ATELIER
POD**
Dubai-Paris-Casablanca
www.atelierpod.com